

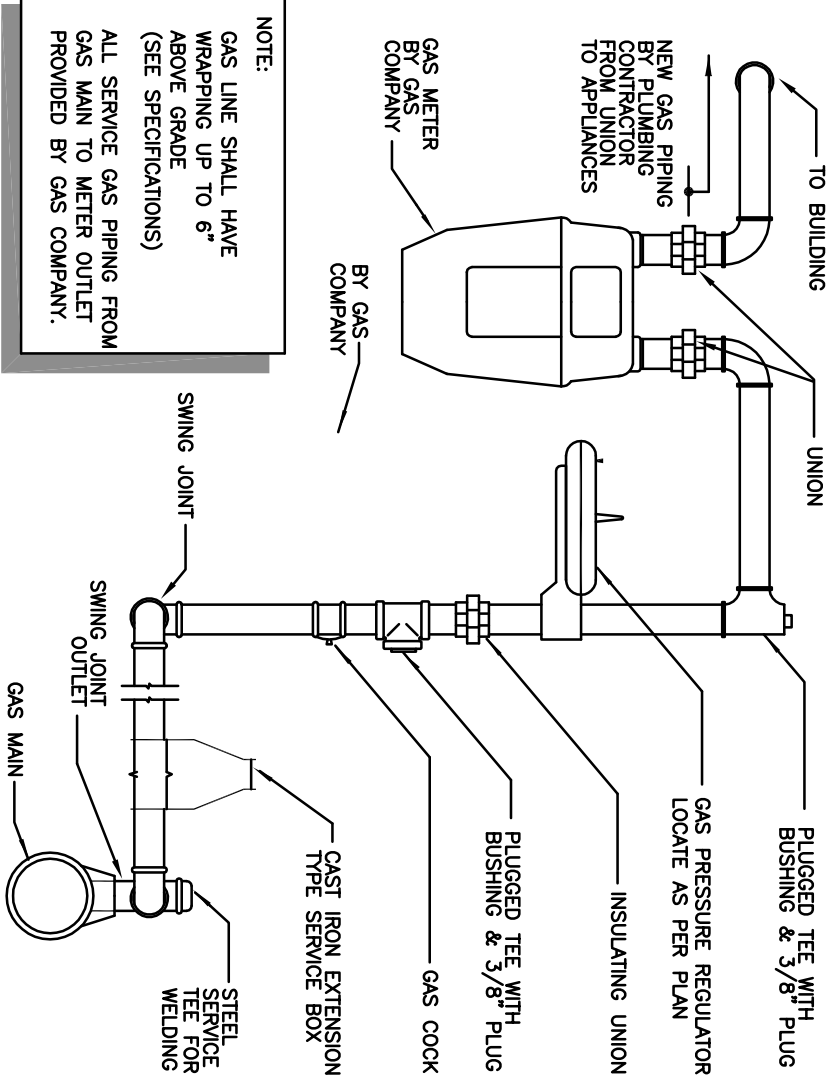


REFER TO ARCHITECTURAL DRAWINGS
FOR KITCHEN LAYOUT OF EQUIPMENT.


REFER TO GAS RISER FOR GAS
PIPING SIZES.

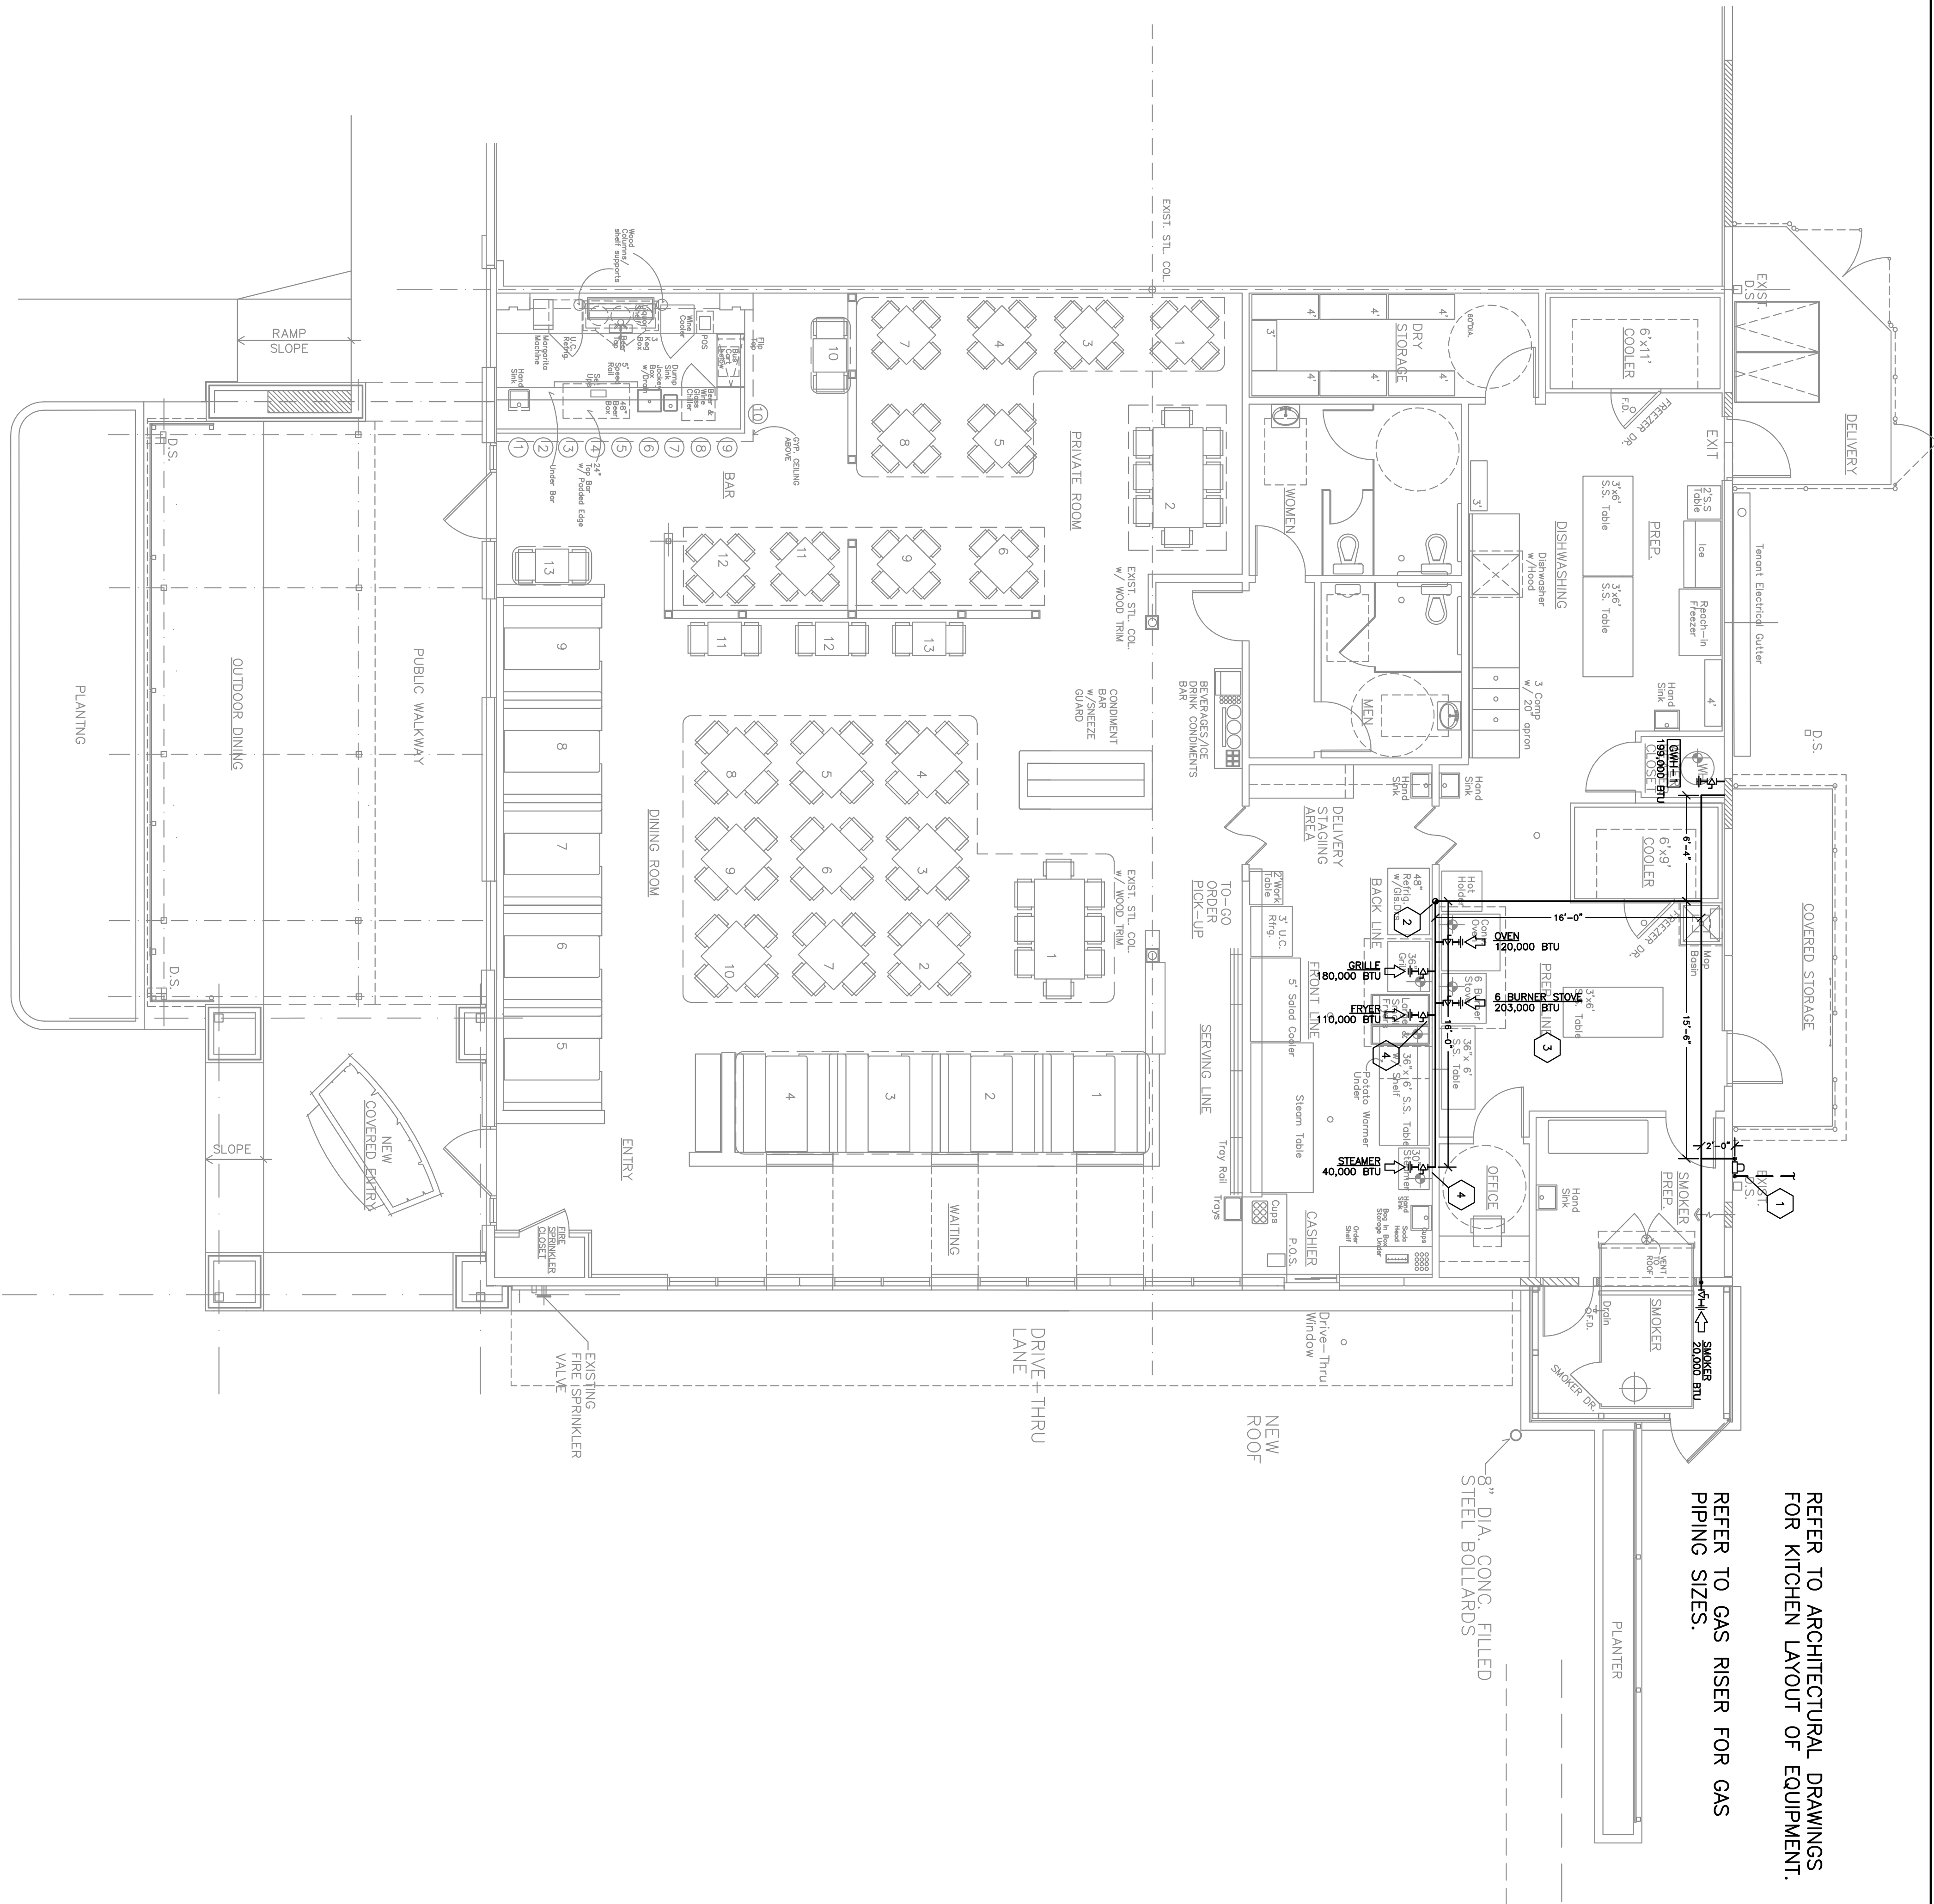

4 GAS SERVICE CONNECTION

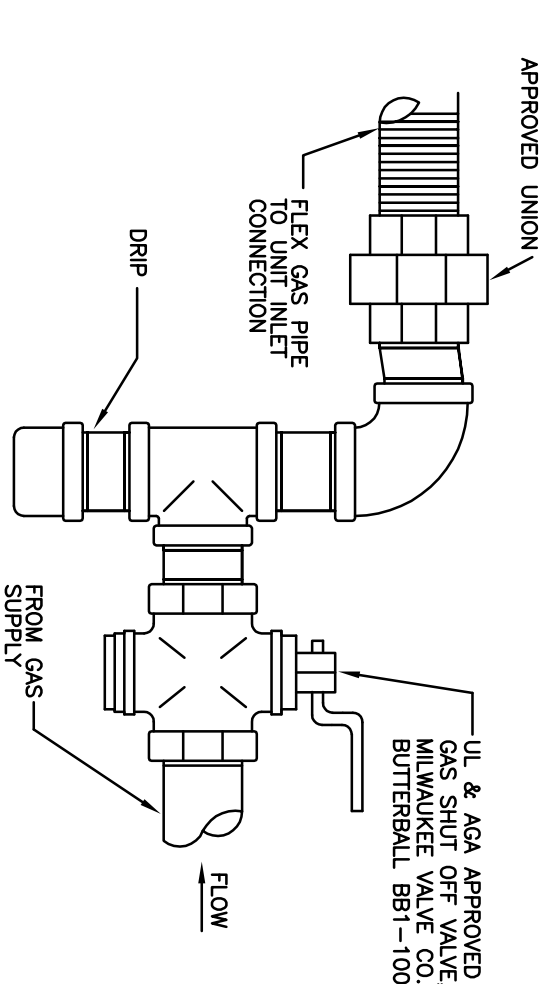

3 TYP. GAS CONNECTION

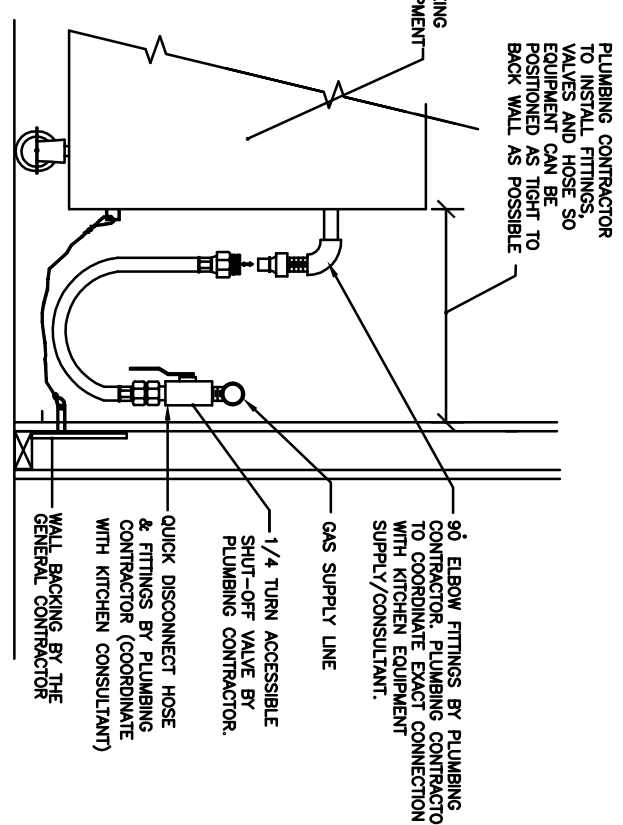

2 GAS CONNECTION AT KITCHEN EQUIP.

- 1 NEW GAS METER AS PER LOCAL GAS COMPANY. VERIFY EXACT LOCATION LOCATIONS.
- 2 PREP GAS PIPING DOWN TO BELOW KITCHEN HOOD. AUTOMATIC GAS SHUT OFF VALVE INSTALLED IN PIPE RE: KITCHEN HOOD DRAWINGS. INSTALL.
- 3 REFER TO KITCHEN VENDOR DRAWINGS FOR GAS CONNECTION LOCATION AND SIZE. CONNECTION TO EQUIPMENT TO BE QUICK DISCONNECT TYPE.
- 4 REFER TO GAS EQUIPMENT CONNECTION DETAIL.

1 GAS KEYED NOTES

5 ROOF/FLOOR PLAN - PLUMBING GAS

SCALE: 1/4" = 1'-0"


ISSUE	DATE	DESCRIPTION
	06/29/11	PERMIT / CONSTRUCTION
	10/13/11	PERMIT / CONSTRUCTION
	11/16/11	CITY COMMENTS

PROJECT:

CONSTRUCTION FOR
Demeris Barbecue

1702 West Loop North
Houston, Texas 77092

ENGINEER

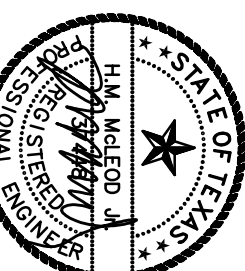

THIS SEAL WAS PLACED
ON THIS PLAN 11/16/11
H.M. McLEOD, P.E.
4797 KENNEDY ST. SUITE 8
HOUSTON, TEXAS 77024
PHONE: (713) 861-5601
OFFICE: (713) 861-5601
CELL: (713) 861-5601
Firm Registration:
H. M. McLeod, P.E. #7-3879
© 2011 H.M. McLeod, P.E.

GAS
PLAN
SHEET NAME:
DRAWN BY:
SCALE: AS NOTED
PROJECT# 11141
DATE 6/17/11

SHEET NUMBER:
P-3